


28600 SF Total

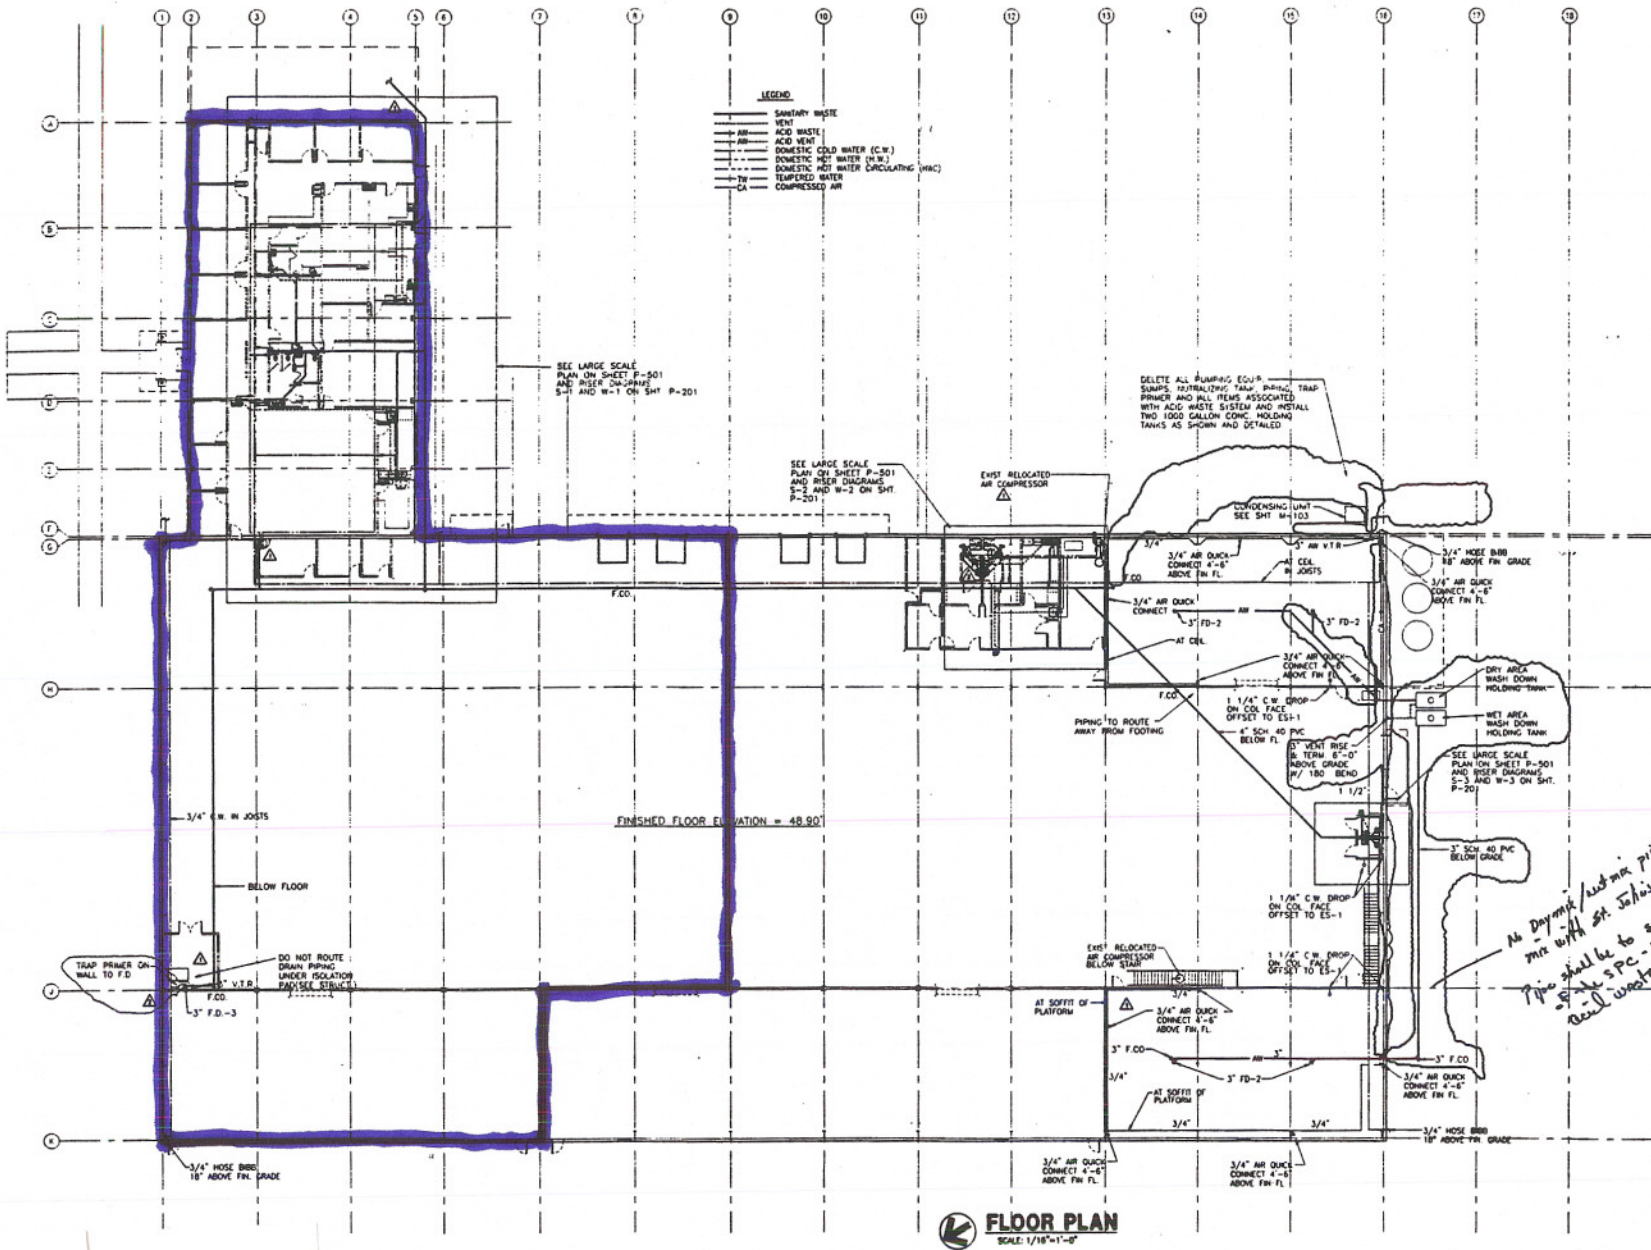

- LEGEND**
- SANITARY WASTE
 - VENT
 - ACID WASTE
 - ACID WASTE
 - DOMESTIC COLD WATER (C.W.)
 - DOMESTIC HOT WATER (H.W.)
 - DOMESTIC HOT WATER CALCULATING (HWC)
 - TEMPERED WATER
 - COMPRESSION WATER
 - CA --- COMPRESSED AIR

RS&H
 Architectural, Engineering, Planning
 and Environmental Services

Reynolds, Smith and Hills, Inc.
 4661 Salisbury Road
 Jacksonville, Florida 32256
 904-296-2000 FAX 904-278-2481
 www.rsandh.com
 FL Lic. No. MC9000018 - EC0000020 - LC0000020

PROTEAM PRODUCTS

PROTEAM PRODUCTS
 THE JOHN GRIVAN CO., INC.
 JACKSONVILLE, FLORIDA

PRICE CONTRACTING, INC.
 6299-6 POWERS AVENUE
 JACKSONVILLE, FLORIDA

CONSULTANTS

REVISIONS

NO.	DESCRIPTION	DATE
1	PERMIT SET	07/02/99
2	REVIEW COMMENT (PRIMERS)	09/03/99

DATE ISSUED: 7-2-99
 REVIEWED BY: REO
 DESIGNED BY: RLM

ASHP PROJECT NUMBER
501-9448-001
 PROTEAM, INC.
 © 1997 REYNOLDS, SMITH AND HILLS, INC.

SHEET TITLE
PLUMBING FLOOR PLAN

PHASE II
100% SUBMITTAL

*As Dynamic / Auto mkr piping shall
 mkr with ST. John's atchy system
 Pipe shall be to section 703.6
 - 5' x 5' PC - 1177 MB. for
 acid waste*

FLOOR PLAN
 SCALE: 1/16"=1'-0"

Exhibit B
 6600 SF Office
 22000 SF Warehouse

Robert B. B.
 12/21/99