


34600 SF Total

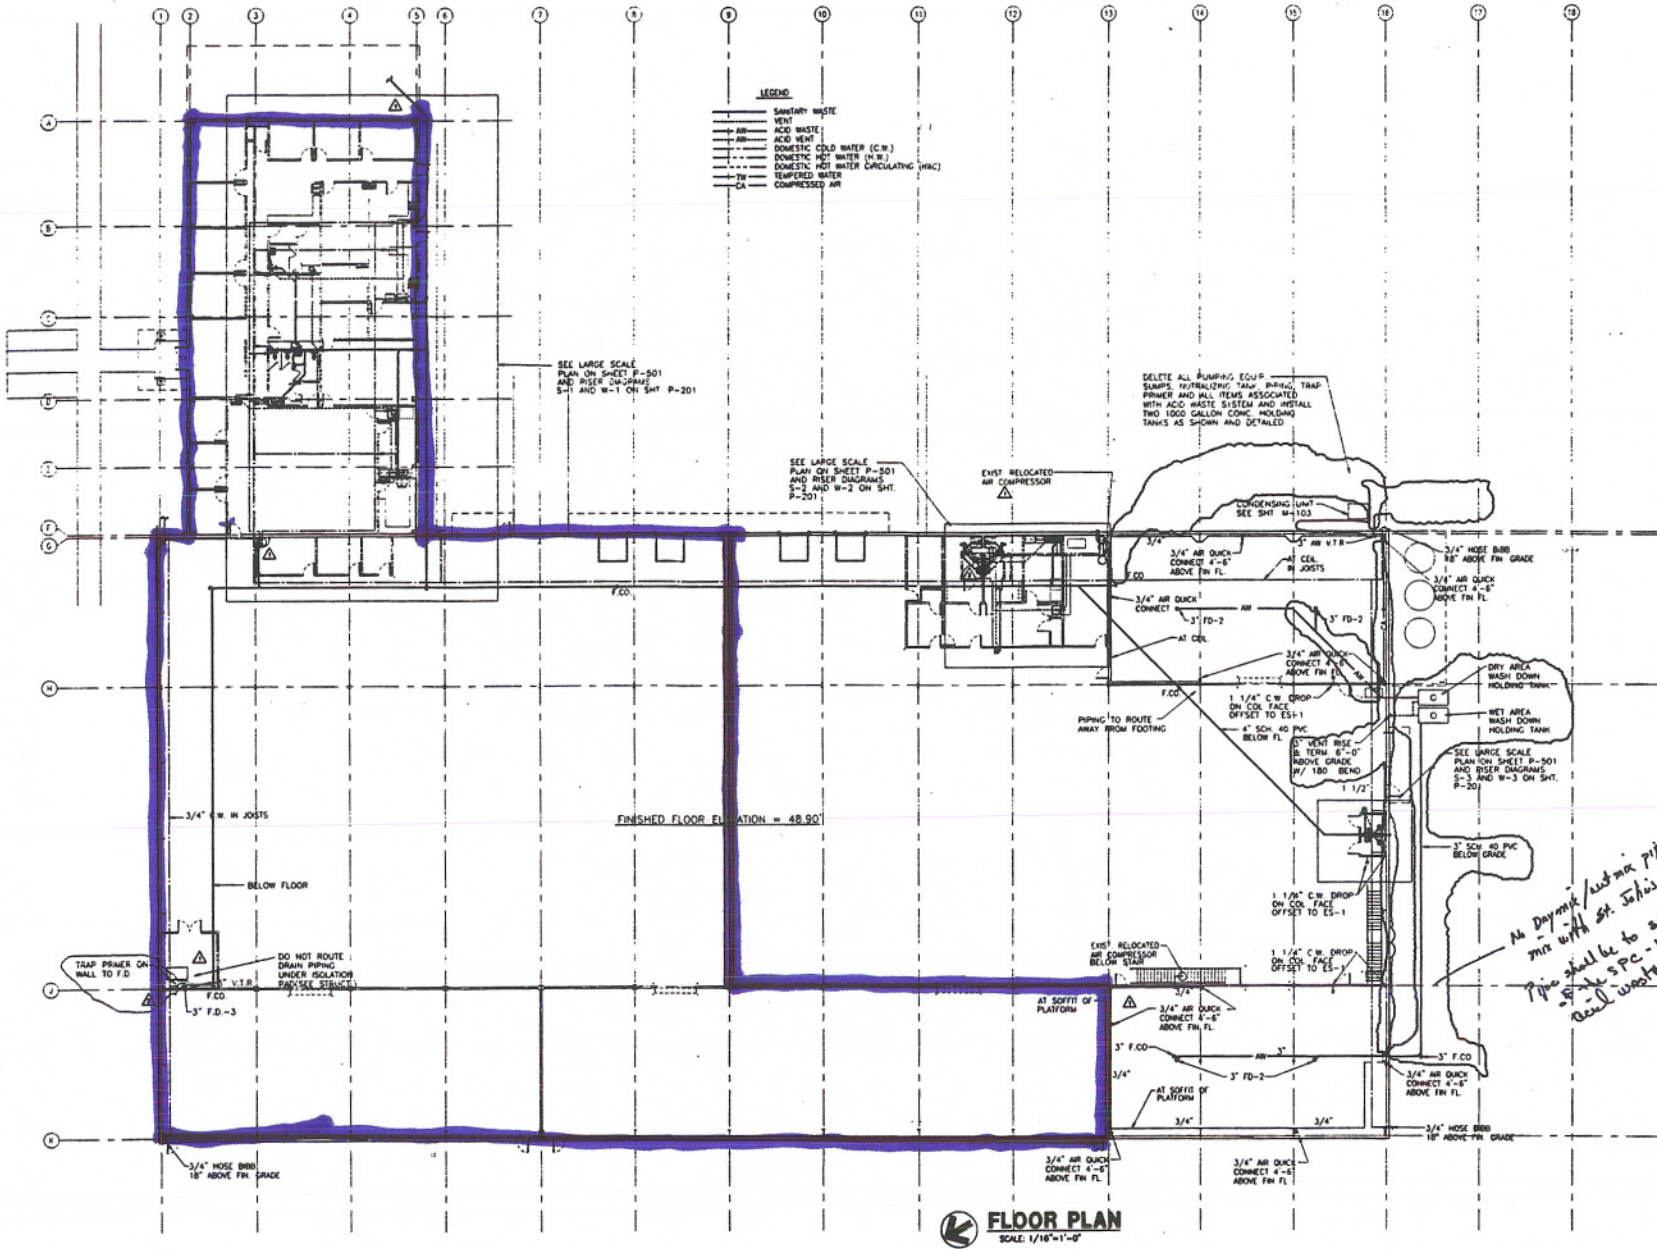

**RS&H**  
 Architectural, Engineering, Planning  
 and Environmental Services  
 Reynolds, Smith and Hills, Inc.  
 4681 Salisbury Road  
 Jacksonville, Florida 32286  
 904-296-2000 FAX 904-279-2491  
 www.rsandh.com  
 FL Cert. Lic. AR001986 - EB0006626 - LC0006629

**PROTEAM PRODUCTS**  
 PROTEAM PRODUCTS  
 THE JOHN GRYVAN CO., INC.  
 JACKSONVILLE, FLORIDA  
 PRICE CONTRACTING, INC.  
 6299-S POWERS AVENUE  
 JACKSONVILLE, FLORIDA

CONSULTANTS

REVISIONS		
NO.	DESCRIPTION	DATE
1	PERMIT SET	07/02/99
2	REVIEW COMMENT (PRIMERS)	09/03/99

DATE ISSUED: 7-2-99  
 REVIEWED BY: RHO  
 DRAWN BY: RLM  
 DESIGNED BY: RLM  
 AEP PROJECT NUMBER  
 601-9448-001  
 PROTEAM INC.  
 © 1997 REYNOLDS, SMITH AND HILLS INC.  
 SHEET TITLE  
**PLUMBING FLOOR PLAN**  
 OFFICE COPY OFFICE COPY  
 OFFICE COPY SHEET NUMBER  
**P101**  
 PHASE II  
 100% SUBMITTAL

Exhibit C  
 6600 SF Office  
 28000 SF Warehouse

*Robert B*  
 12/21/99